




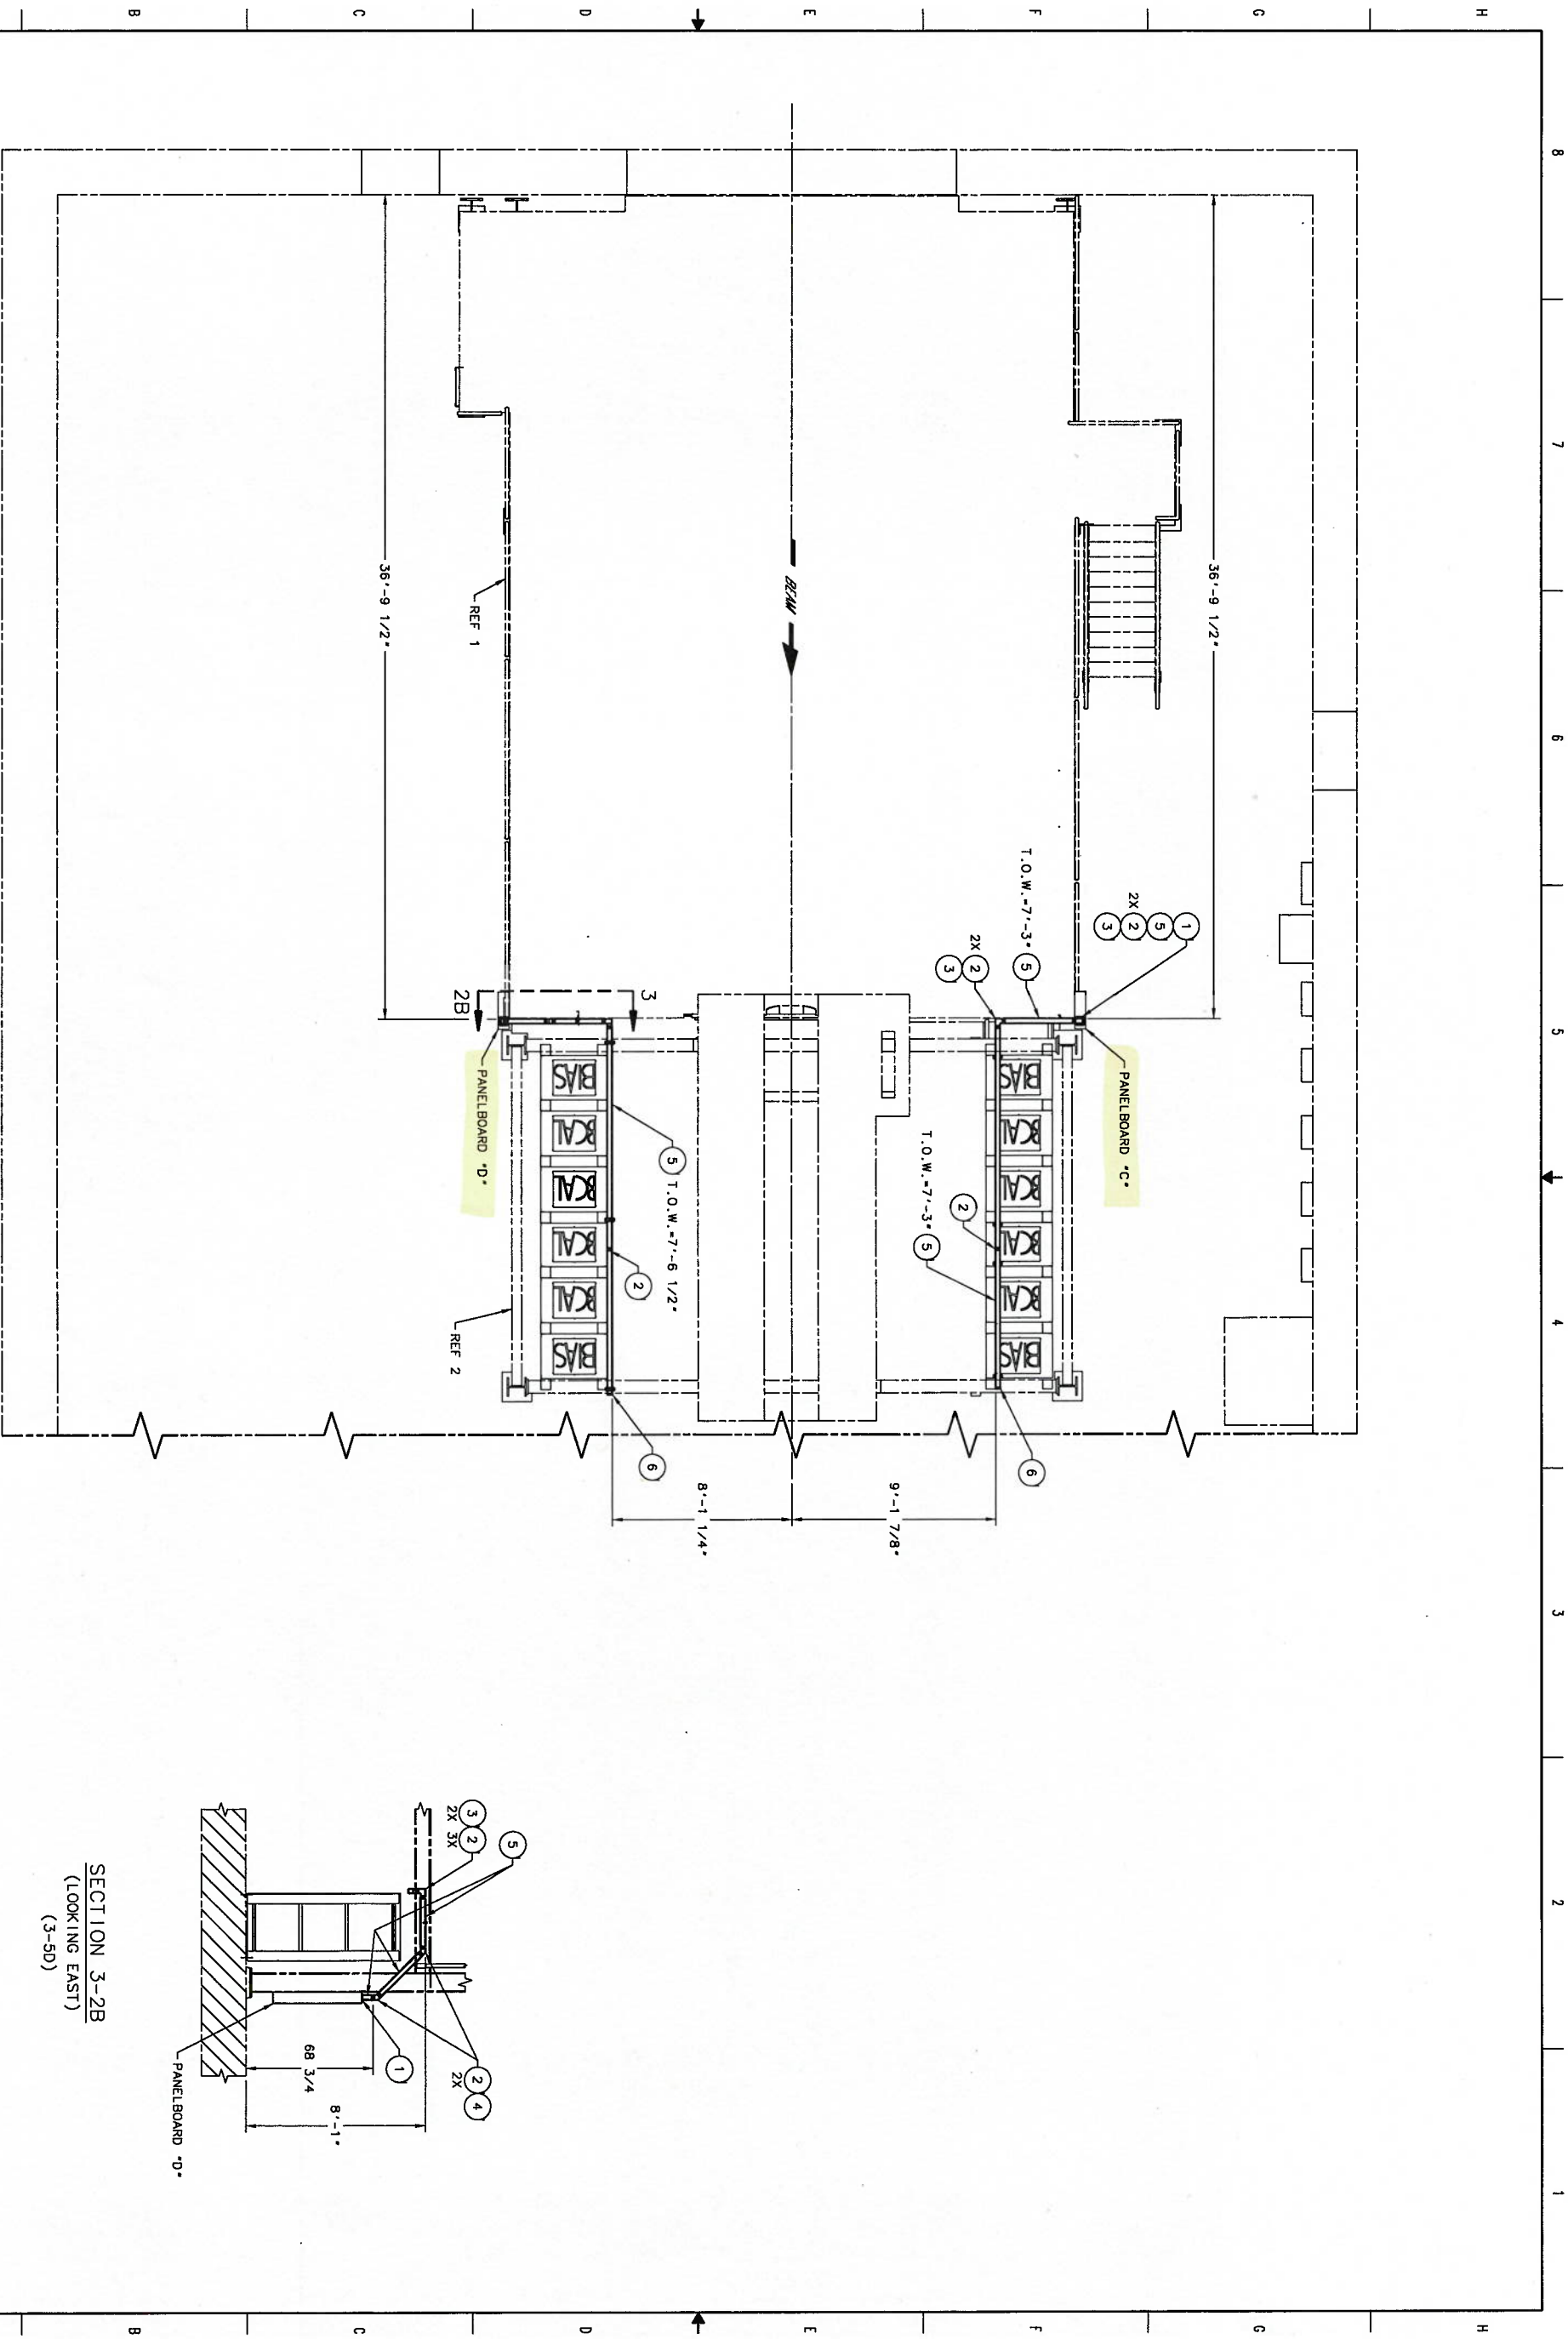


REV.	DATE	BY	CHKD.	APP.	NOTED	DATE	BY	CHKD.	APP.
1	10-01-1002	1	1	1	1	1	1	1	1

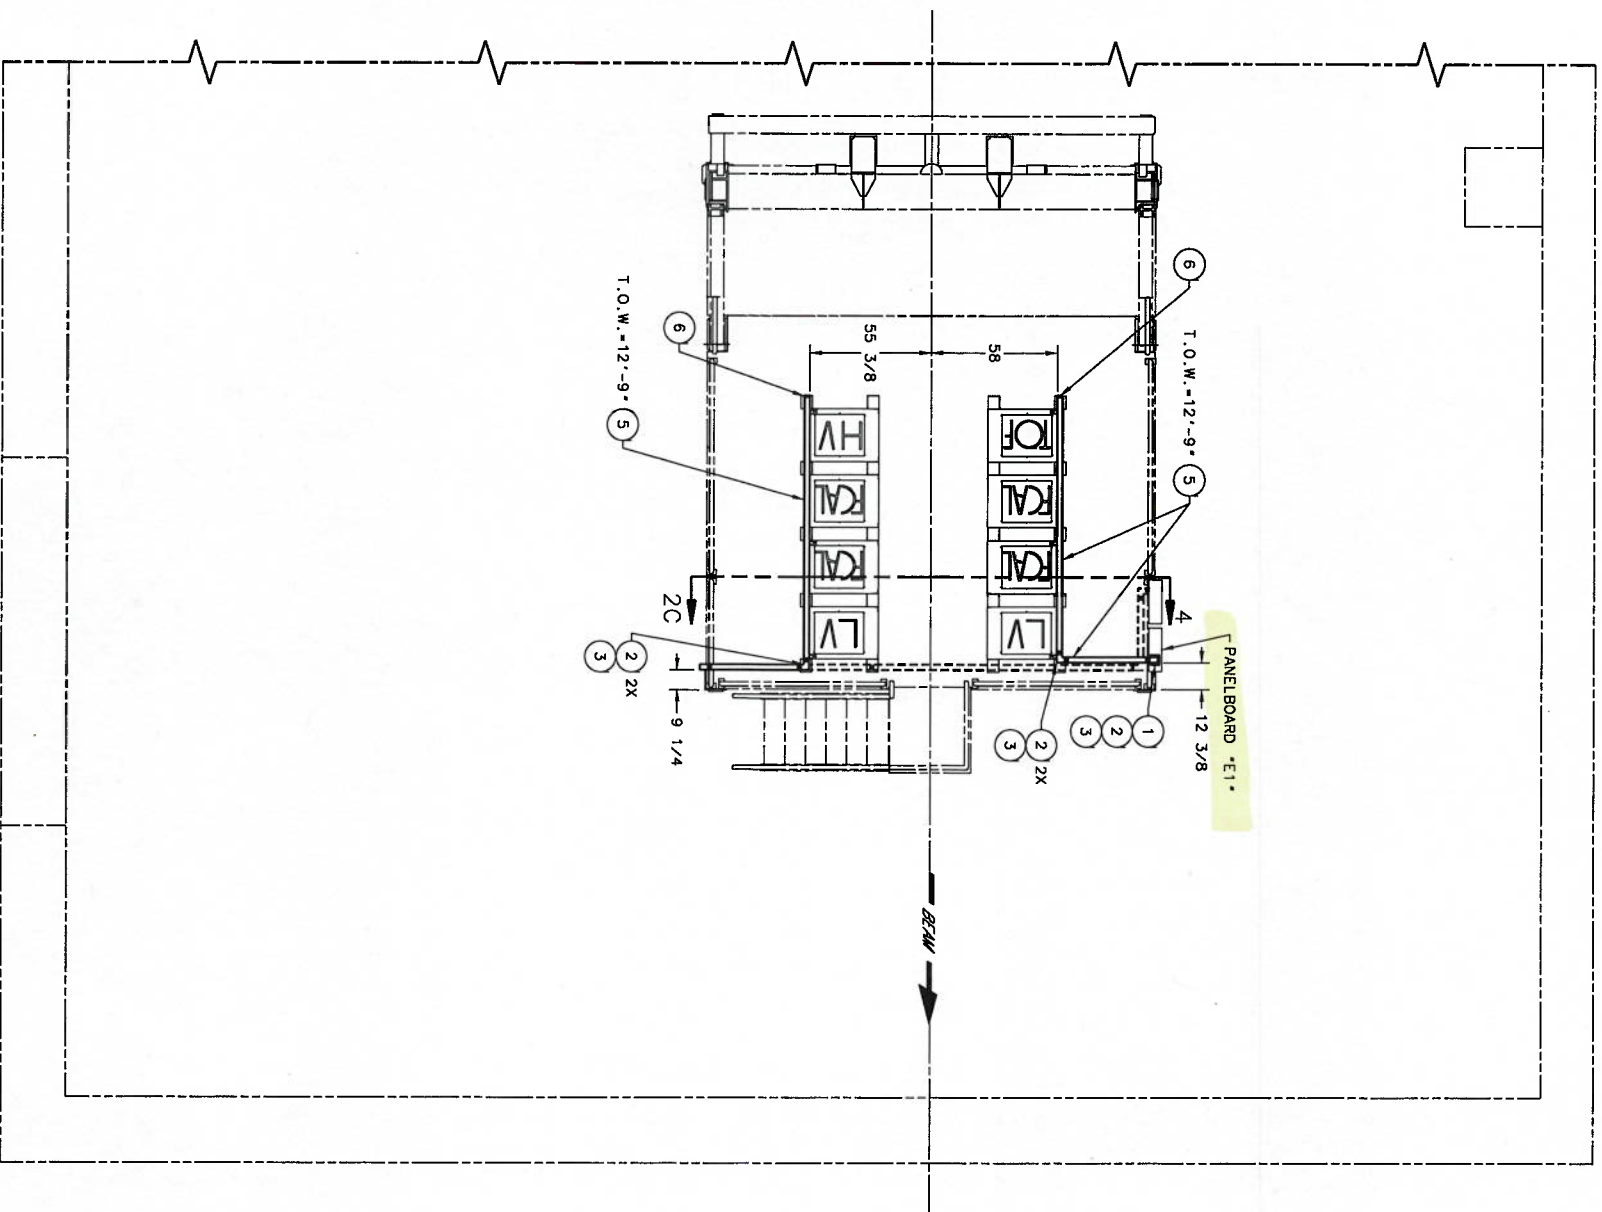

VIEW 4-6A
WIREWAY RUNS FROM PANELS
E1 & E2)

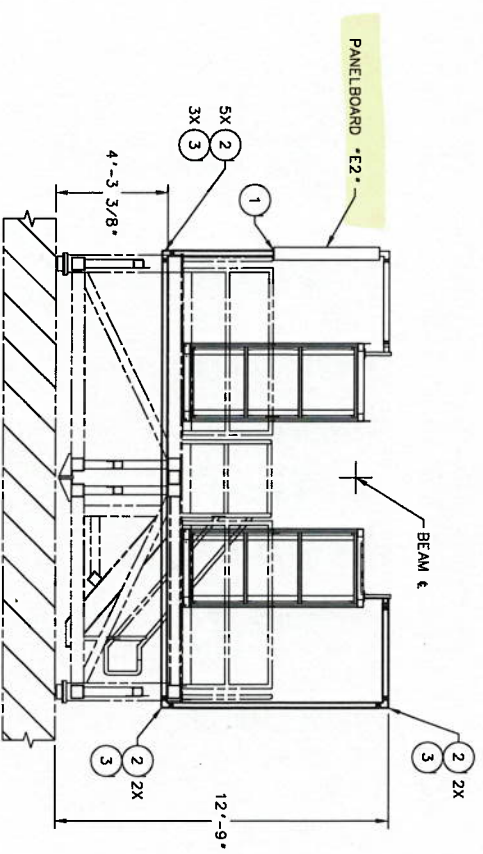

SECTION 4-2C
(LOOKING EAST)
(4-6F)

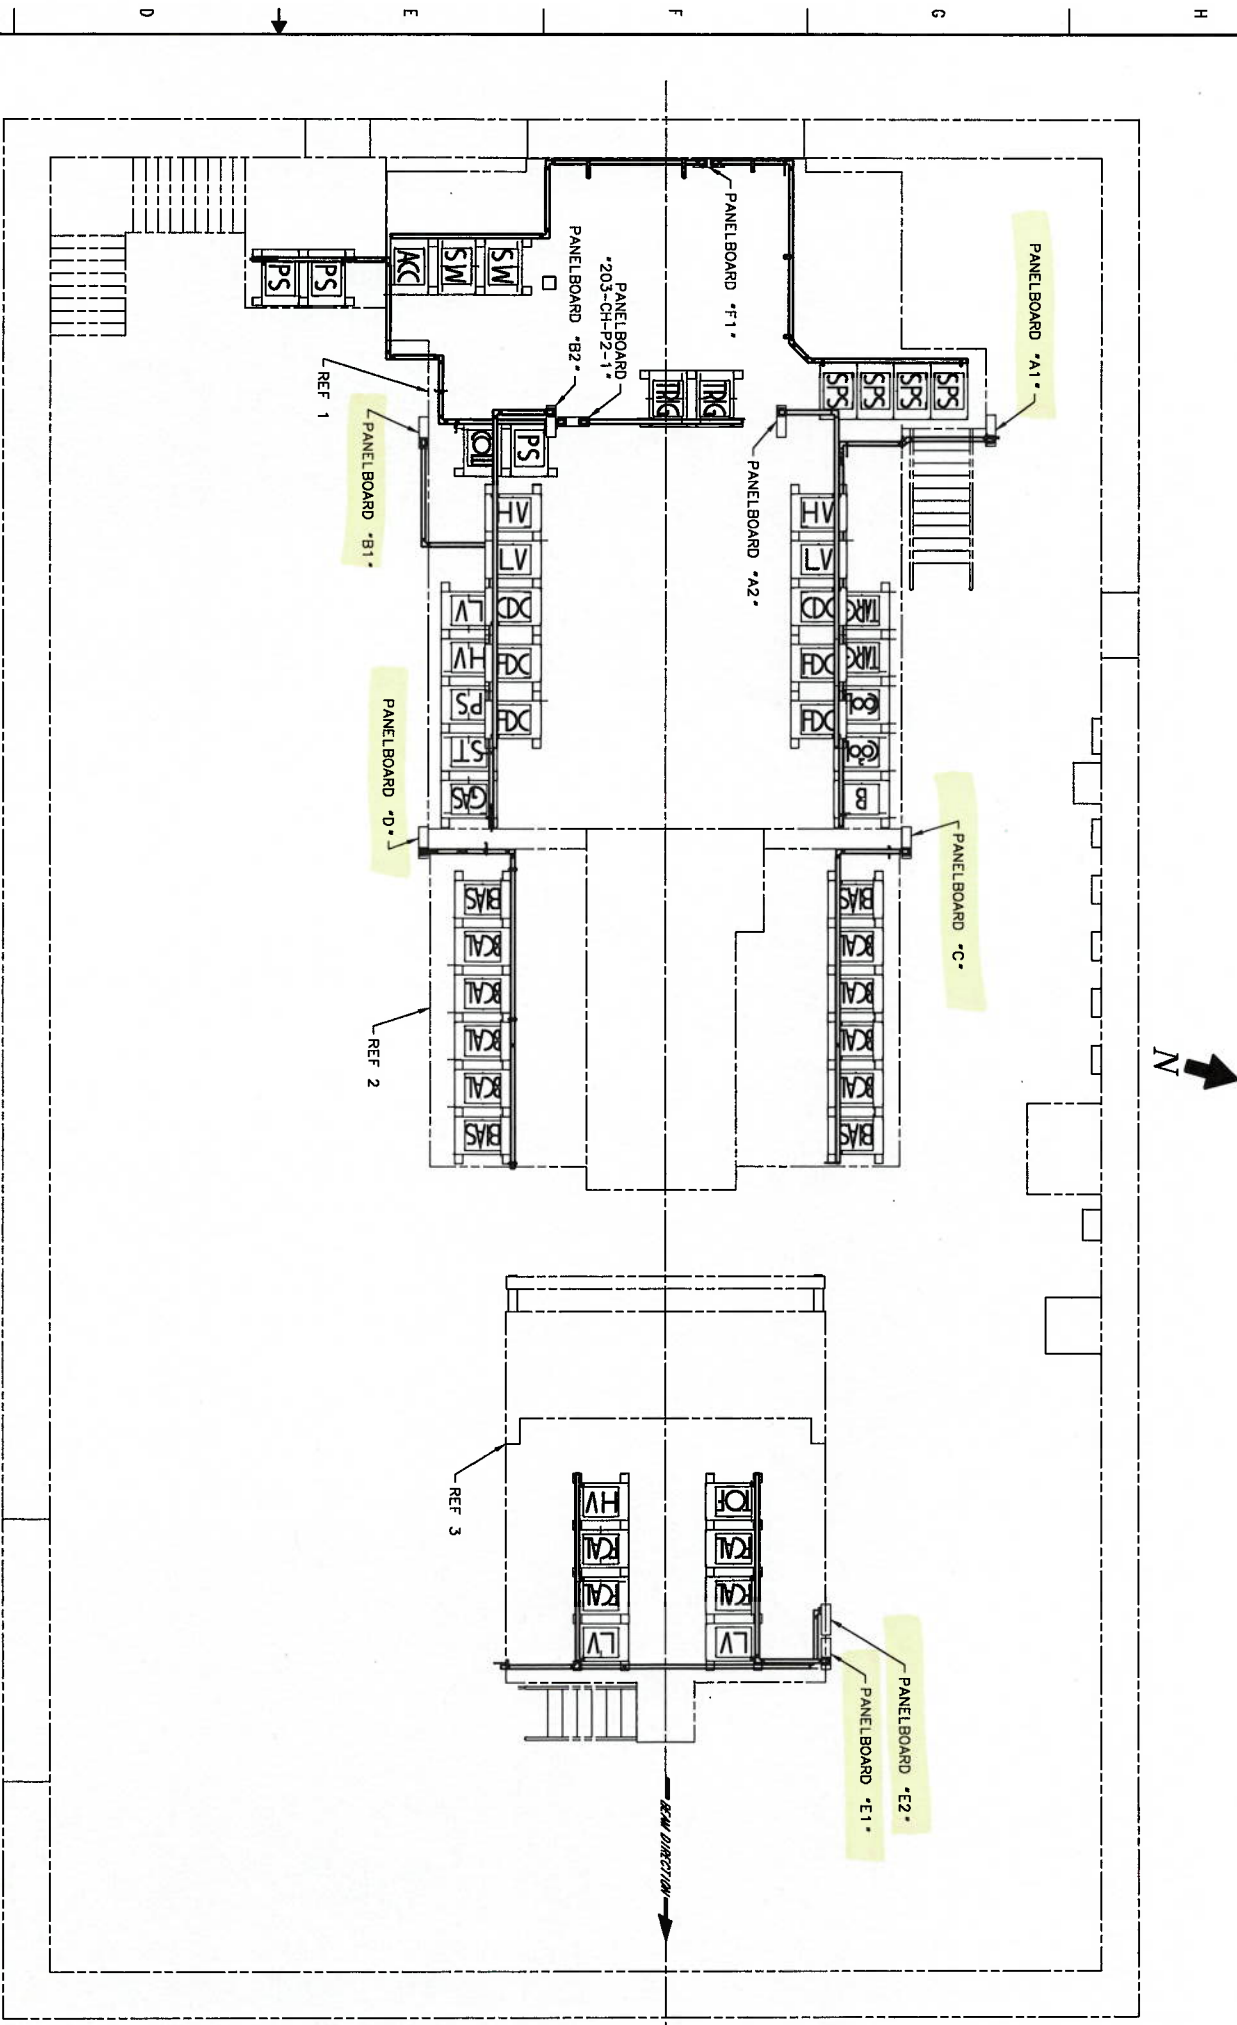

PLAN VIEW - HALL D

NOTES:

- 1) DIMENSIONS GREATER THAN 72 INCHES ARE SHOWN IN FEET-INCHES.
- 2) QUANTITIES SHOWN IN THE BILL OF MATERIALS ARE AS DESIGNED TRIM, FIELD MODIFICATION, OR ANY MACHINING PROCESSES.
- 3) LOCATION TOLERANCE FOR ELECTRICAL COMPONENTS AND ELECTRICAL RIGS IS +/- 8 TO ALLOW FOR ANY FIELD MODIFICATIONS NEEDED TO AVOID INTERFERENCES WITH OTHER EXISTING HALL SERVICE COMPONENTS.
- 4) T.O.W. IS THE ELEVATION MEASUREMENT FROM THE CONCRETE FLOOR TO THE TOP OF THE WIREWAY.
- 5) SQUARE DUCT WIREWAY USED IS 2-1/2 SQ. GENERAL PURPOSE NEMA TYPE-1.
- 6) SEE REFERENCE 4 FOR RACK LOCATIONS.
- 7) SEE REFERENCE 6 FOR PANEL SCHEDULES AND LOCATIONS.
- 8) SUGGESTED SOURCE OR JLAB APPROVED ALTERNATE:
SCHNEIDER ELECTRIC
(757) 461-1290
WWW.SCHNEIDER-ELECTRIC.US/
MAYER ELECTRIC SUPPLY
(757) 873-0055
WWW.MAYERELECTRIC.COM
- 9) MOUNTING HARDWARE AND HANGERS (ITEMS 7, 8, & 9) ARE TO BE USED ON AN AS REQUIRED BASIS AT THE INSTALLING TECHNICIANS DISCRETION. THEIR USE MAY NOT BE IDENTIFIED IN THE BODY OF THE DRAWING.

REFERENCE NO.	DRAWING NO.	DRAWING TITLE
1	DD0000-05-00-1000	UPSTREAM PLATFORM ASSEMBLY
2	DD0000-00-00-1001	CRYO PLATFORM INSTALLATION ASSY
3	DD0000-05-00-1021	FCAL - DOWNSTREAM PLATFORM TOP ASSY
4	DD0000-00-00-4000	HALL-D RACK LOCATION LAYOUT
5	DD0000-06-00-1000	PAIR SPECTROMETER SHIELDING ASSY
6	DD0000-10-01-1001	PANELBOARD LAYOUT PLAN

REVISION	DATE	DESCRIPTION	APPROVED
1	2024-01-10	ISSUED FOR CONSTRUCTION	[Signature]
2	2024-01-15	REVISED BASED ON COMMENTS	[Signature]
3	2024-01-20	REVISED BASED ON COMMENTS	[Signature]
4	2024-01-25	REVISED BASED ON COMMENTS	[Signature]

ITEM NO.	DESCRIPTION	QUANTITY	UNIT	REVISION
1	BRACKET (4-12)	8	STEEL	8.9
2	SCHNEIDER LDB25H	1	STEEL	5.8.9
3	SCHNEIDER LDB2H	1	STEEL	5.8.9
4	SCHNEIDER LDB25H	1	STEEL	5.8.9
5	SCHNEIDER LDB25H	1	STEEL	5.8.9
6	SCHNEIDER LDB25H	1	STEEL	5.8.9
7	SCHNEIDER LDB25H	1	STEEL	5.8.9
8	SCHNEIDER LDB25H	1	STEEL	5.8.9
9	SCHNEIDER LDB25H	1	STEEL	5.8.9
10	SCHNEIDER LDB25H	1	STEEL	5.8.9
11	SCHNEIDER LDB25H	1	STEEL	5.8.9
12	SCHNEIDER LDB25H	1	STEEL	5.8.9